



FIRST FLOOR PLAN

SCALE: 1/4"=1'-0"

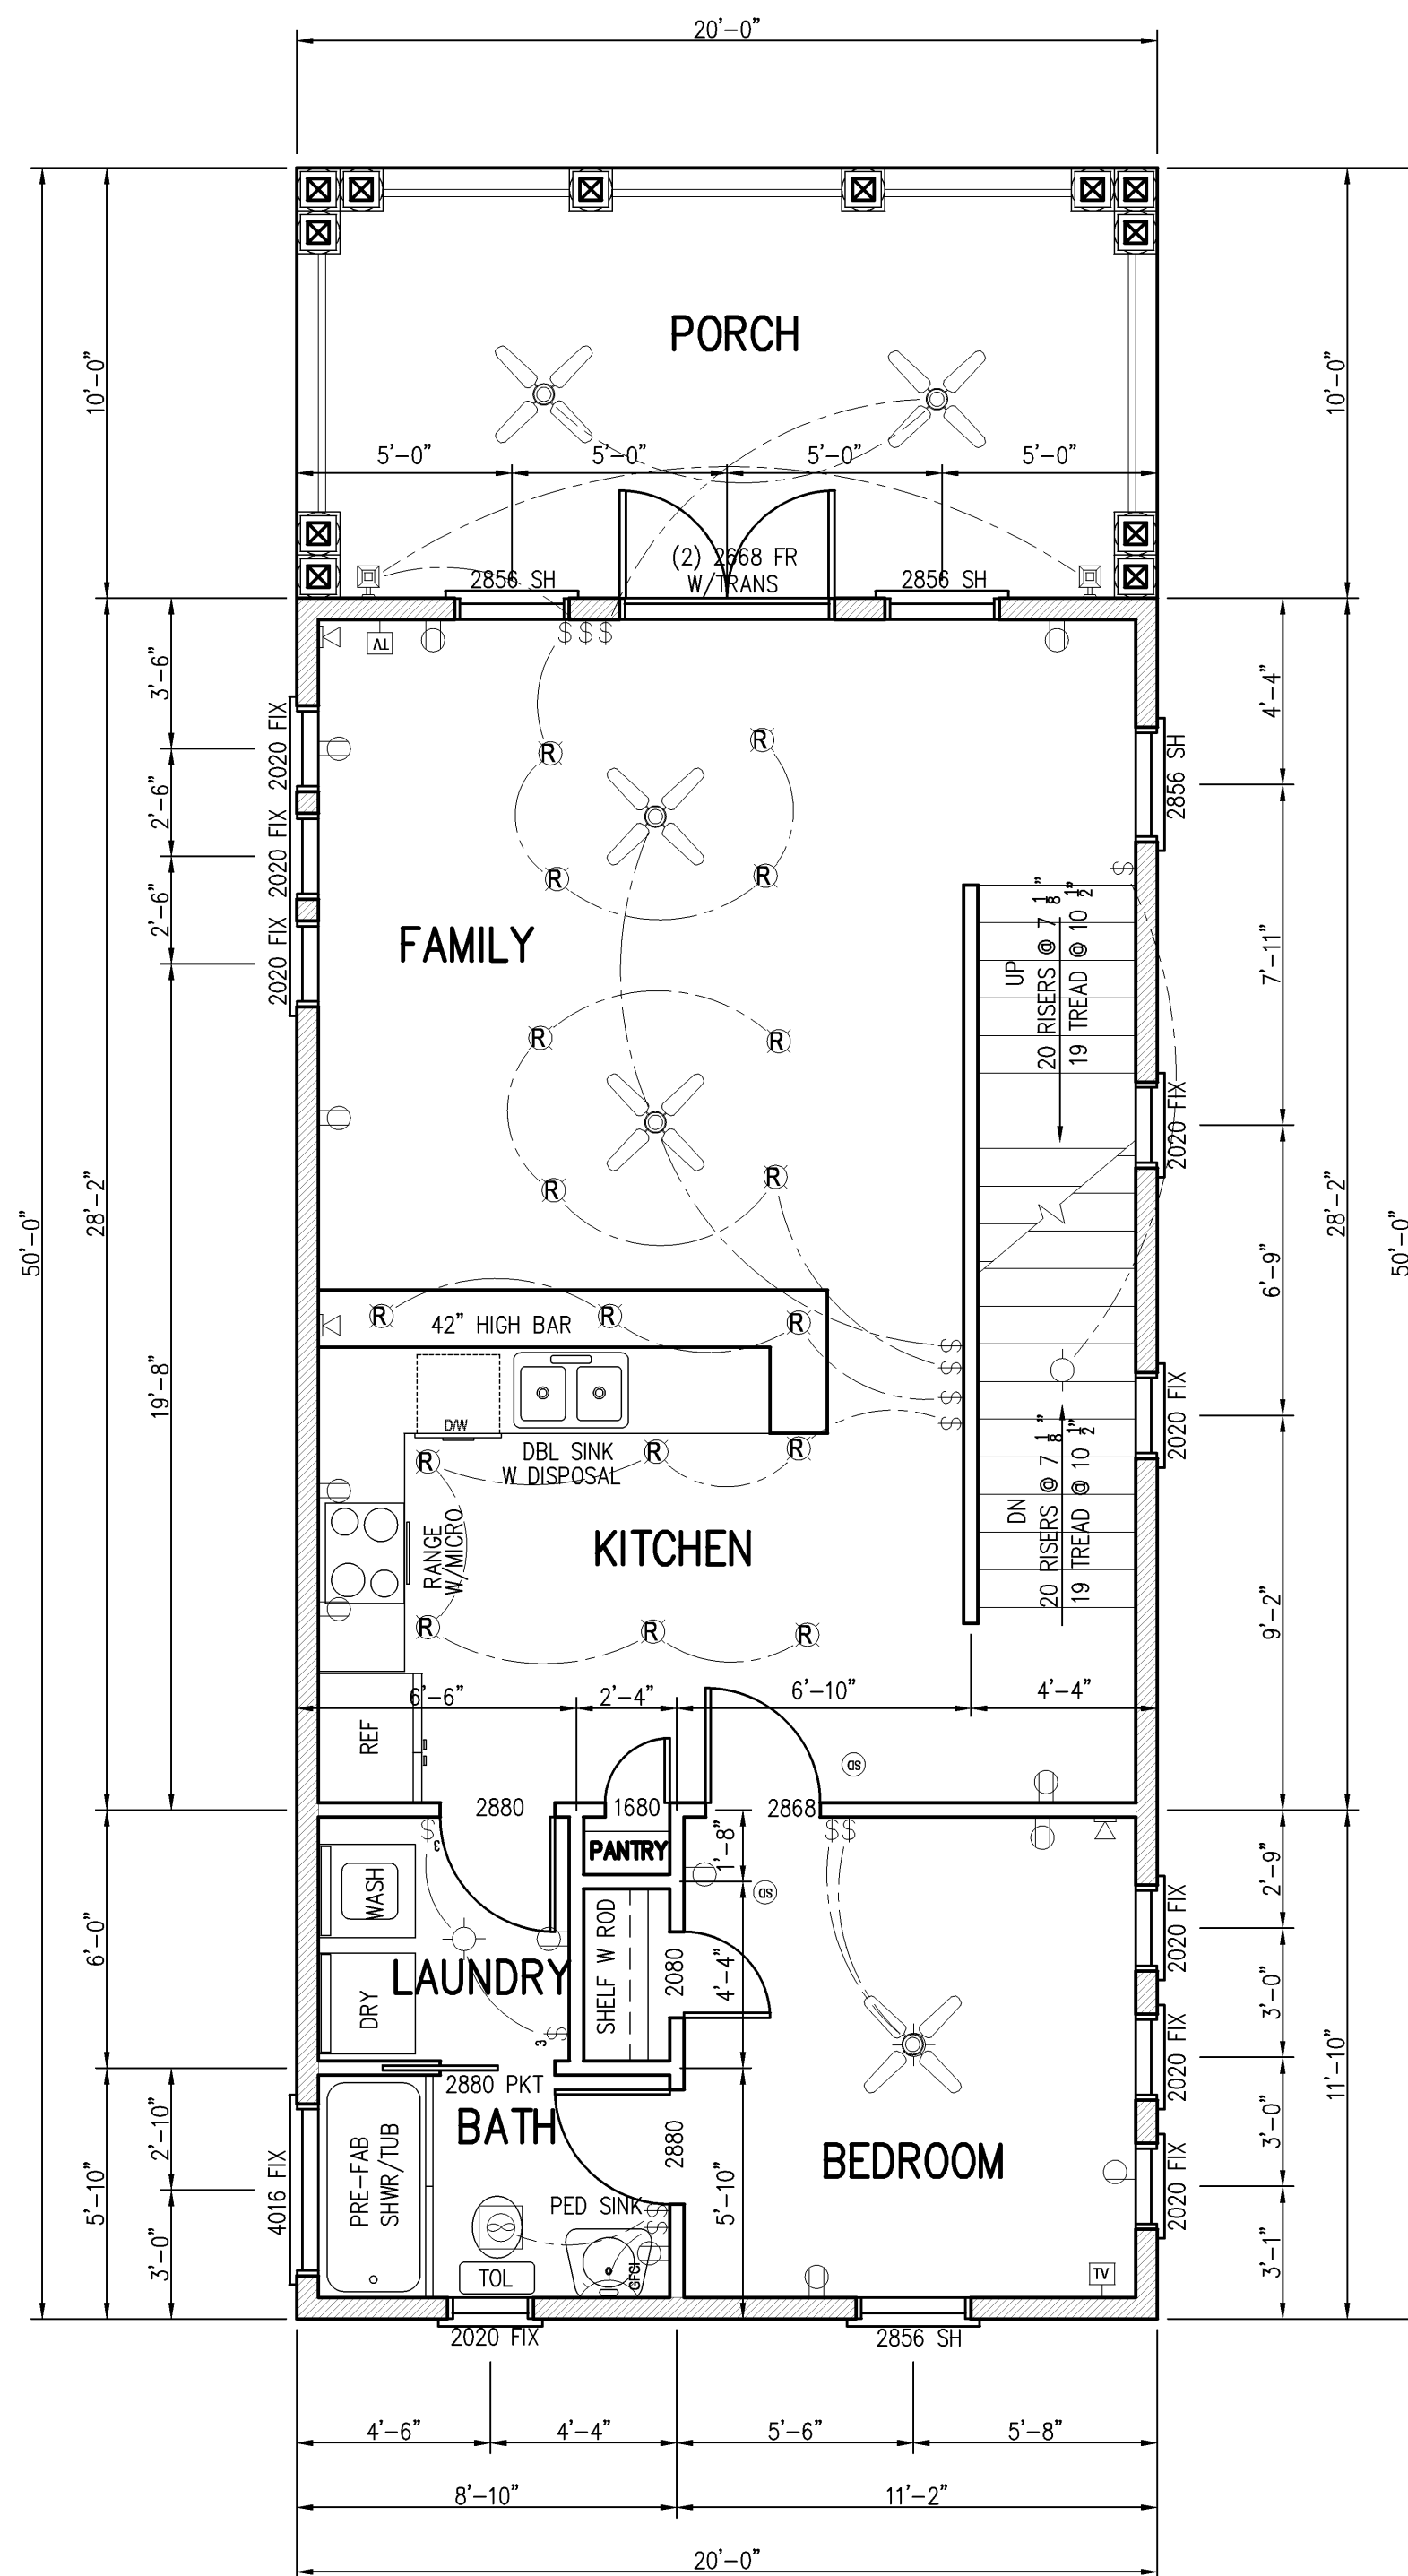

SECOND FLOOR PLAN

SCALE: 1/4"=1'-0"

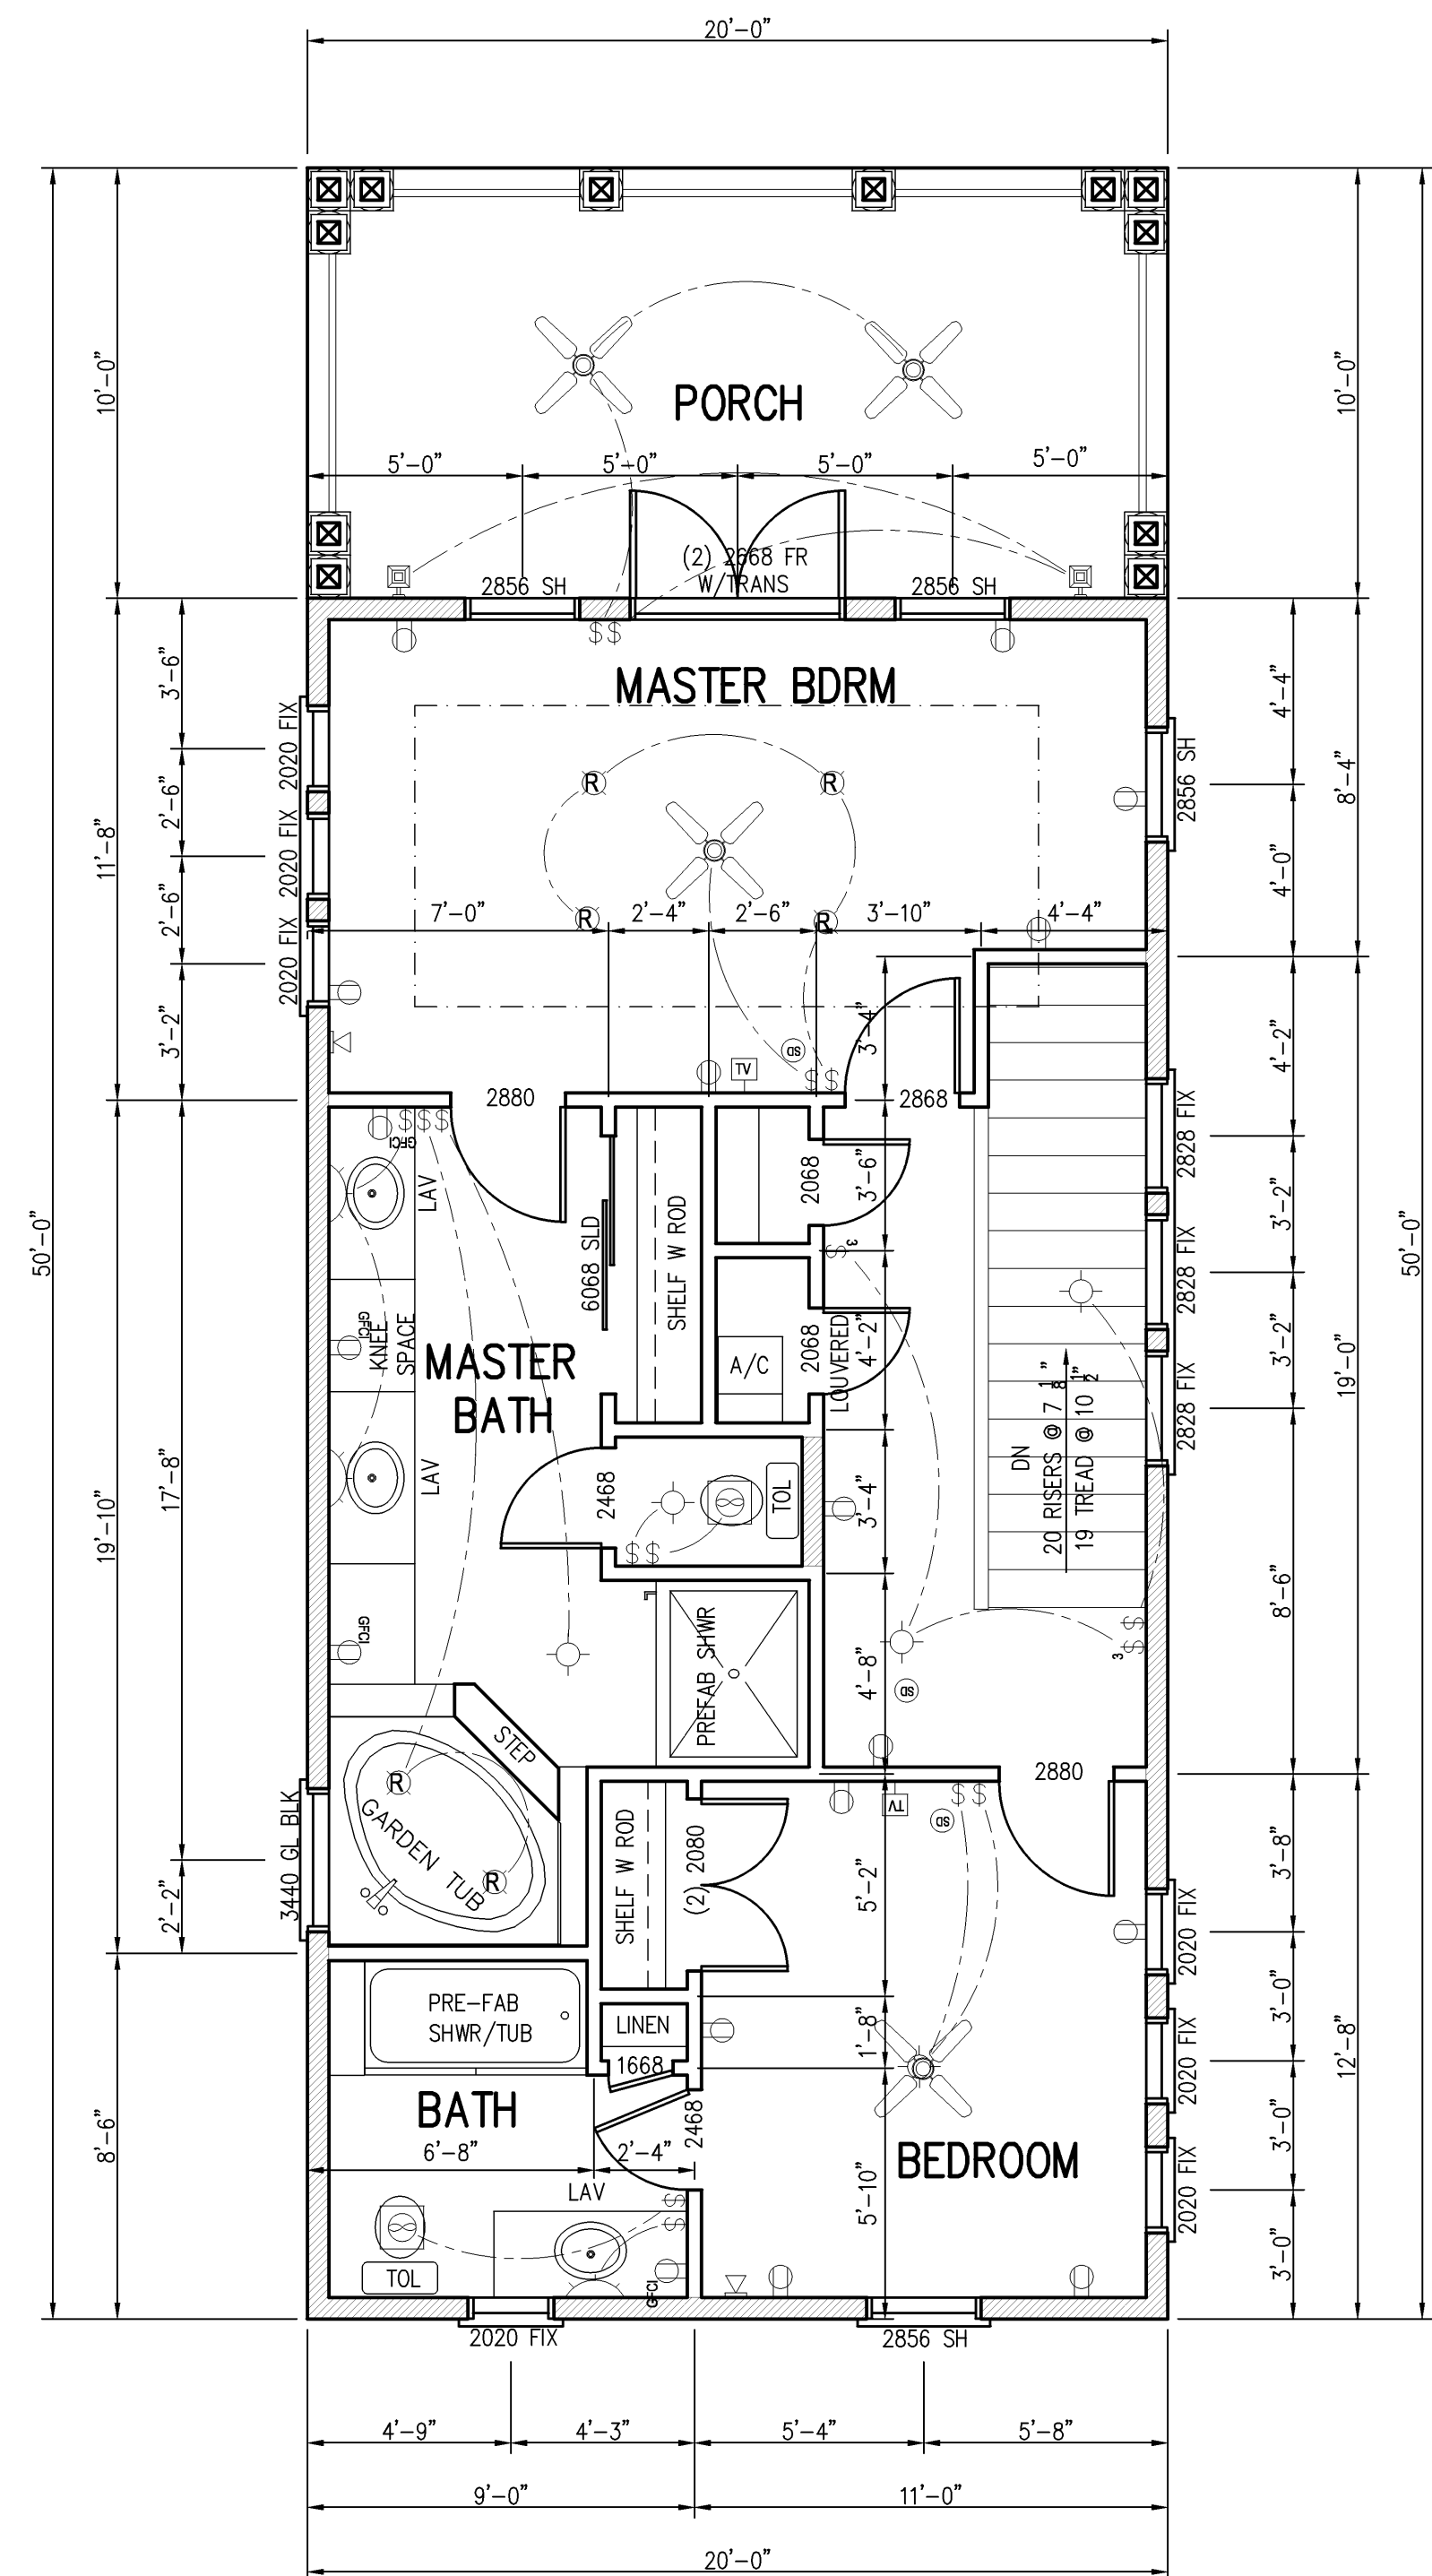

THIRD FLOOR PLAN

SCALE: 1/4"=1'-0"

WALL LEGEND

-
-
NOTE:
 FOR WINDOW & DOOR DESIGN PRESSURES
 SEE COMPONENT TABLE SHEET A.1

ELECTRICAL LEGEND

SYMBOL	DESCRIPTION	SYMBOL	DESCRIPTION
	CEILING OUTLET, RECESSED		THERMOSTAT
	WALL OUTLET		DOOR BELL
	CEILING OUTLET W/ EXHAUST FAN, SURFACE MOUNTED		SMOKE DETECTOR
	FLUORESCENT FIXTURE		DISTRIBUTION PANEL
	DUPLEX RECEPTACLE		SINGLE POLE SWITCH
	220 VOLT OUTLET, AMPERAGE AS NOTED		THREE POLE SWITCH
	DUPLEX RECEPTACLE, WATER PROOF		DIMMER SWITCH
	GROUND FAULT INTERCEPTOR		FLOOD LIGHT
	TELEPHONE OUTLET		CEILING FAN
	TELEVISION OUTLET		