


FOURTH FLOOR PLAN

SCALE: 1/4"=1'-0"

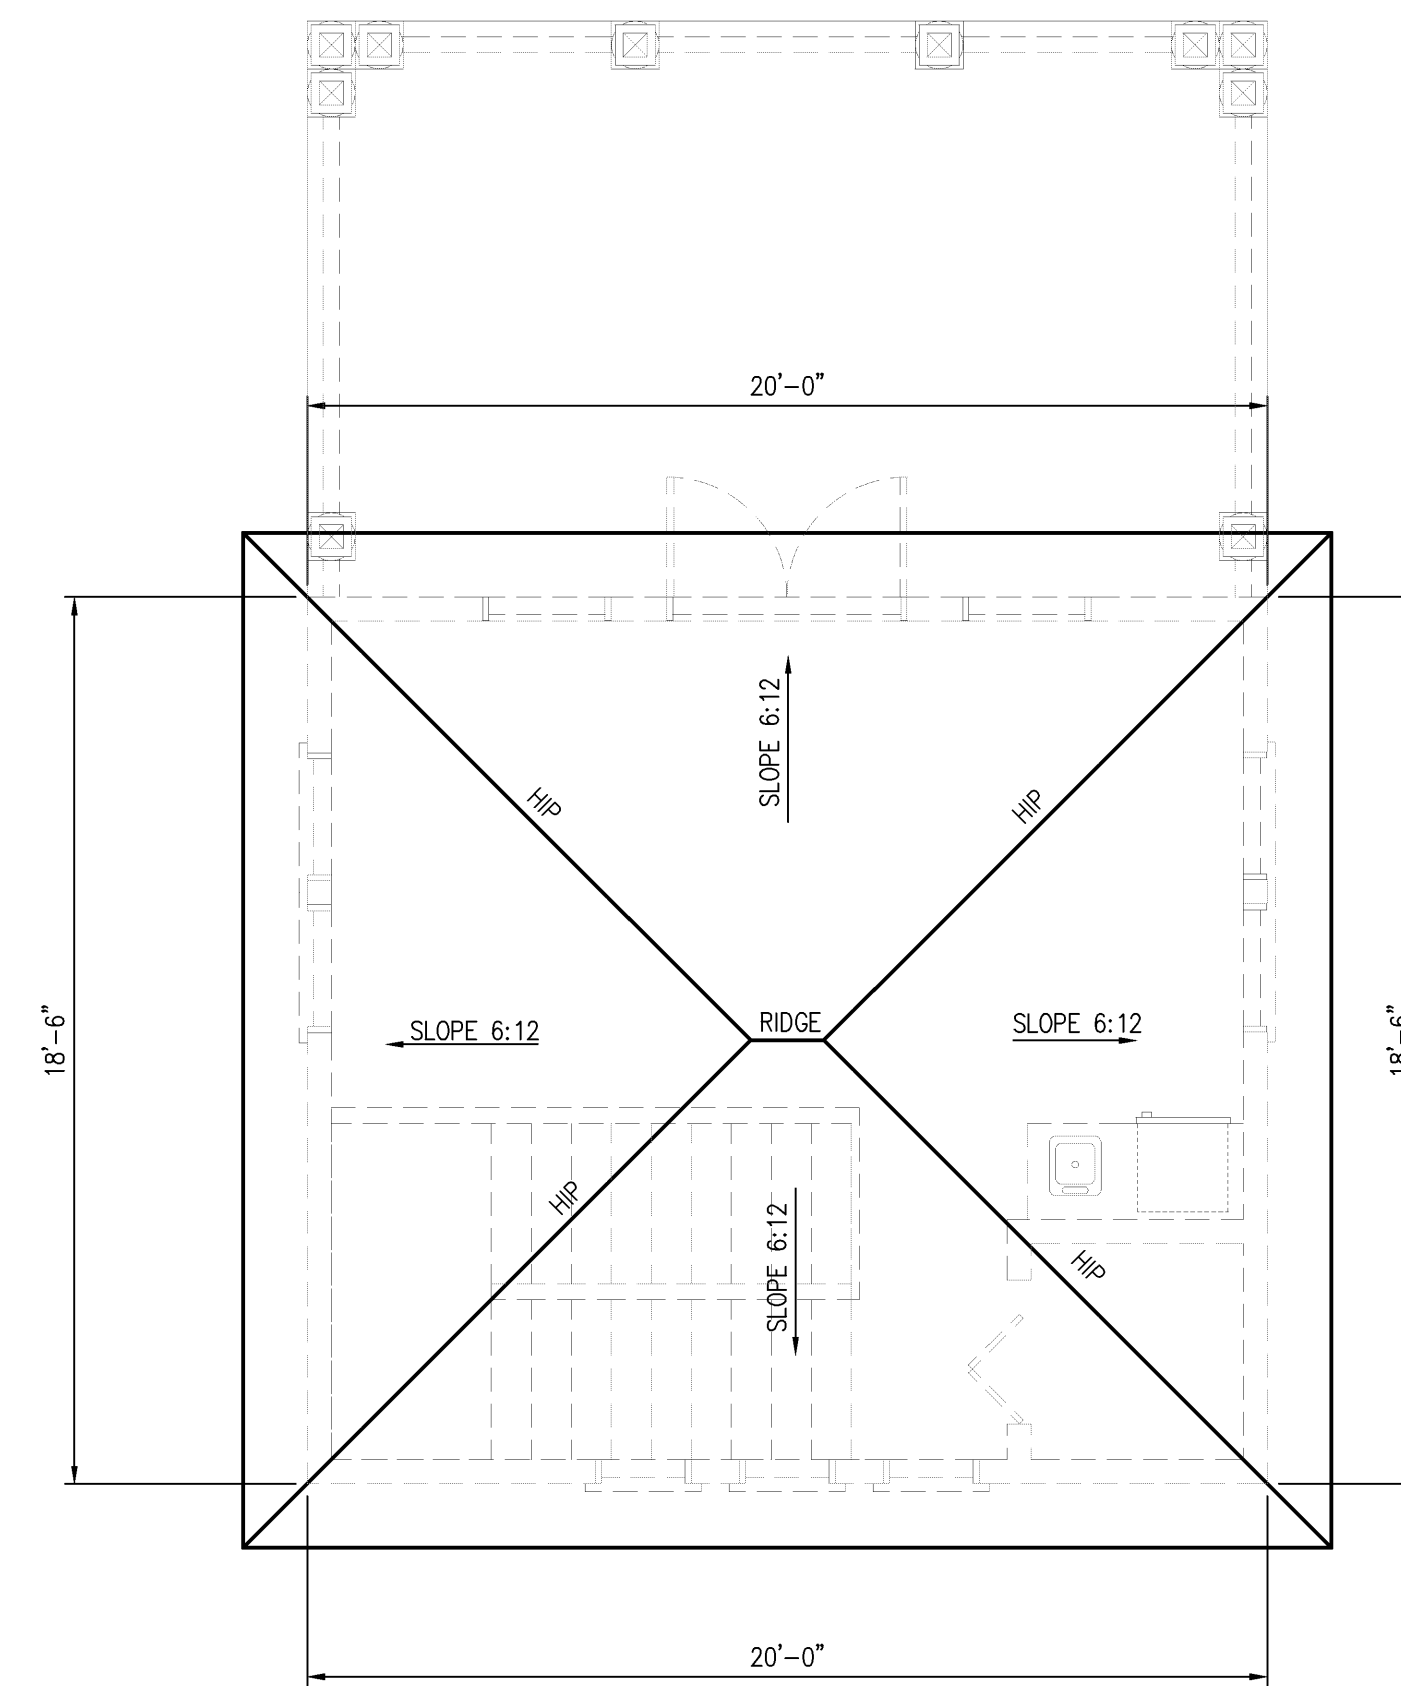

FOURTH FLOOR ROOF PLAN

SCALE: 1/4"=1'-0"

WALL LEGEND

- 2x4 STUDS @ 16" O.C.
- 1ST FLR - (2) 2x6 STUDS @ 16" O.C.
- 2ND & 3RD FLR - 2x6 STUDS @ 16" O.C.
- (2) 2x8 STUDS @ 12" O.C. OR (2) 2x10 STUDS @ 16" O.C.
- (3) TRIPLE JAMB FULL LENGTH STUDS
- (4) QUADRUPLE JAMB FULL LENGTH STUDS
- (5) QUADRUPLE JAMB FULL LENGTH STUDS
- (X) SIMPSON PHD2 HOLDDOWN (OR EQUAL)

NOTE:
FOR WINDOW & DOOR DESIGN PRESSURES
SEE COMPONENT TABLE SHEET A.1

ELECTRICAL LEGEND

SYMBOL	DESCRIPTION	SYMBOL	DESCRIPTION
	CEILING OUTLET, RECESSED		THERMOSTAT
	WALL OUTLET		DOOR BELL
	CEILING OUTLET W/ EXHAUST FAN, SURFACE MOUNTED		SMOKE DETECTOR
	FLUORESCENT FIXTURE		DISTRIBUTION PANEL
	DUPLEX RECEPTACLE		SINGLE POLE SWITCH
	220 VOLT OUTLET, AMPERAGE AS NOTED		THREE POLE SWITCH
	DUPLEX RECEPTACLE, WATER PROOF		DIMMER SWITCH
	GROUND FAULT INTERCEPTOR		FLOOD LIGHT
	TELEPHONE OUTLET		CEILING FAN
	TELEVISION OUTLET		

CARR ENGINEERING & CONSTRUCTION, INC.
 Michael V. Carr P.E. License # 26675
 CIVIL & STRUCTURAL ENGINEERING CONSTRUCTION
 13305 Panama City Beach Parkway
 Panama City Beach, Florida 32407
 Phone (850) 230-8812 • Fax (850) 230-8819

Prepared by
Mitch Baxley
 17320 Panama City Beach Parkway, Suite 103
 Panama City Beach, Florida 32413
 (850) 233-0191

A NEW RESIDENCE FOR
CABANA VILLAS TYPE "C"
 OCEANVIEW DRIVE
 PANAMA CITY BEACH, FLORIDA

DRAWN BY	MEM
REVISIONS	
DATE OF ISSUE	1/29/06
CHECKED BY	
PROJECT NO	2005-035C
SHEET TITLE	FOURTH FLOOR & ROOF PLANS
SHEET NO	A.5